

ECM 9a: 676 kW
 UNIT ON
 BASEMENT
 FLOOR;
 AUXILIARIES ON
 A PLATFORM
 ABOVE

SFGLD 360
 ENGINE

GEN
 676 kW

BASEMENT FLOOR PLAN

SCALE: 1/8" = 1'0"


SCHEMATIC DESIGN
 APPROXIMATE DIMENSIONS
 PROGRESS 01-7-13

WHIPPLE HALL PLANT
 RHODE ISLAND COLLEGE
 PROVIDENCE, RI



111 Sporn Street, Suite 410
 Framingham, Massachusetts 01701
 (508) 881-8800

ECM 9a

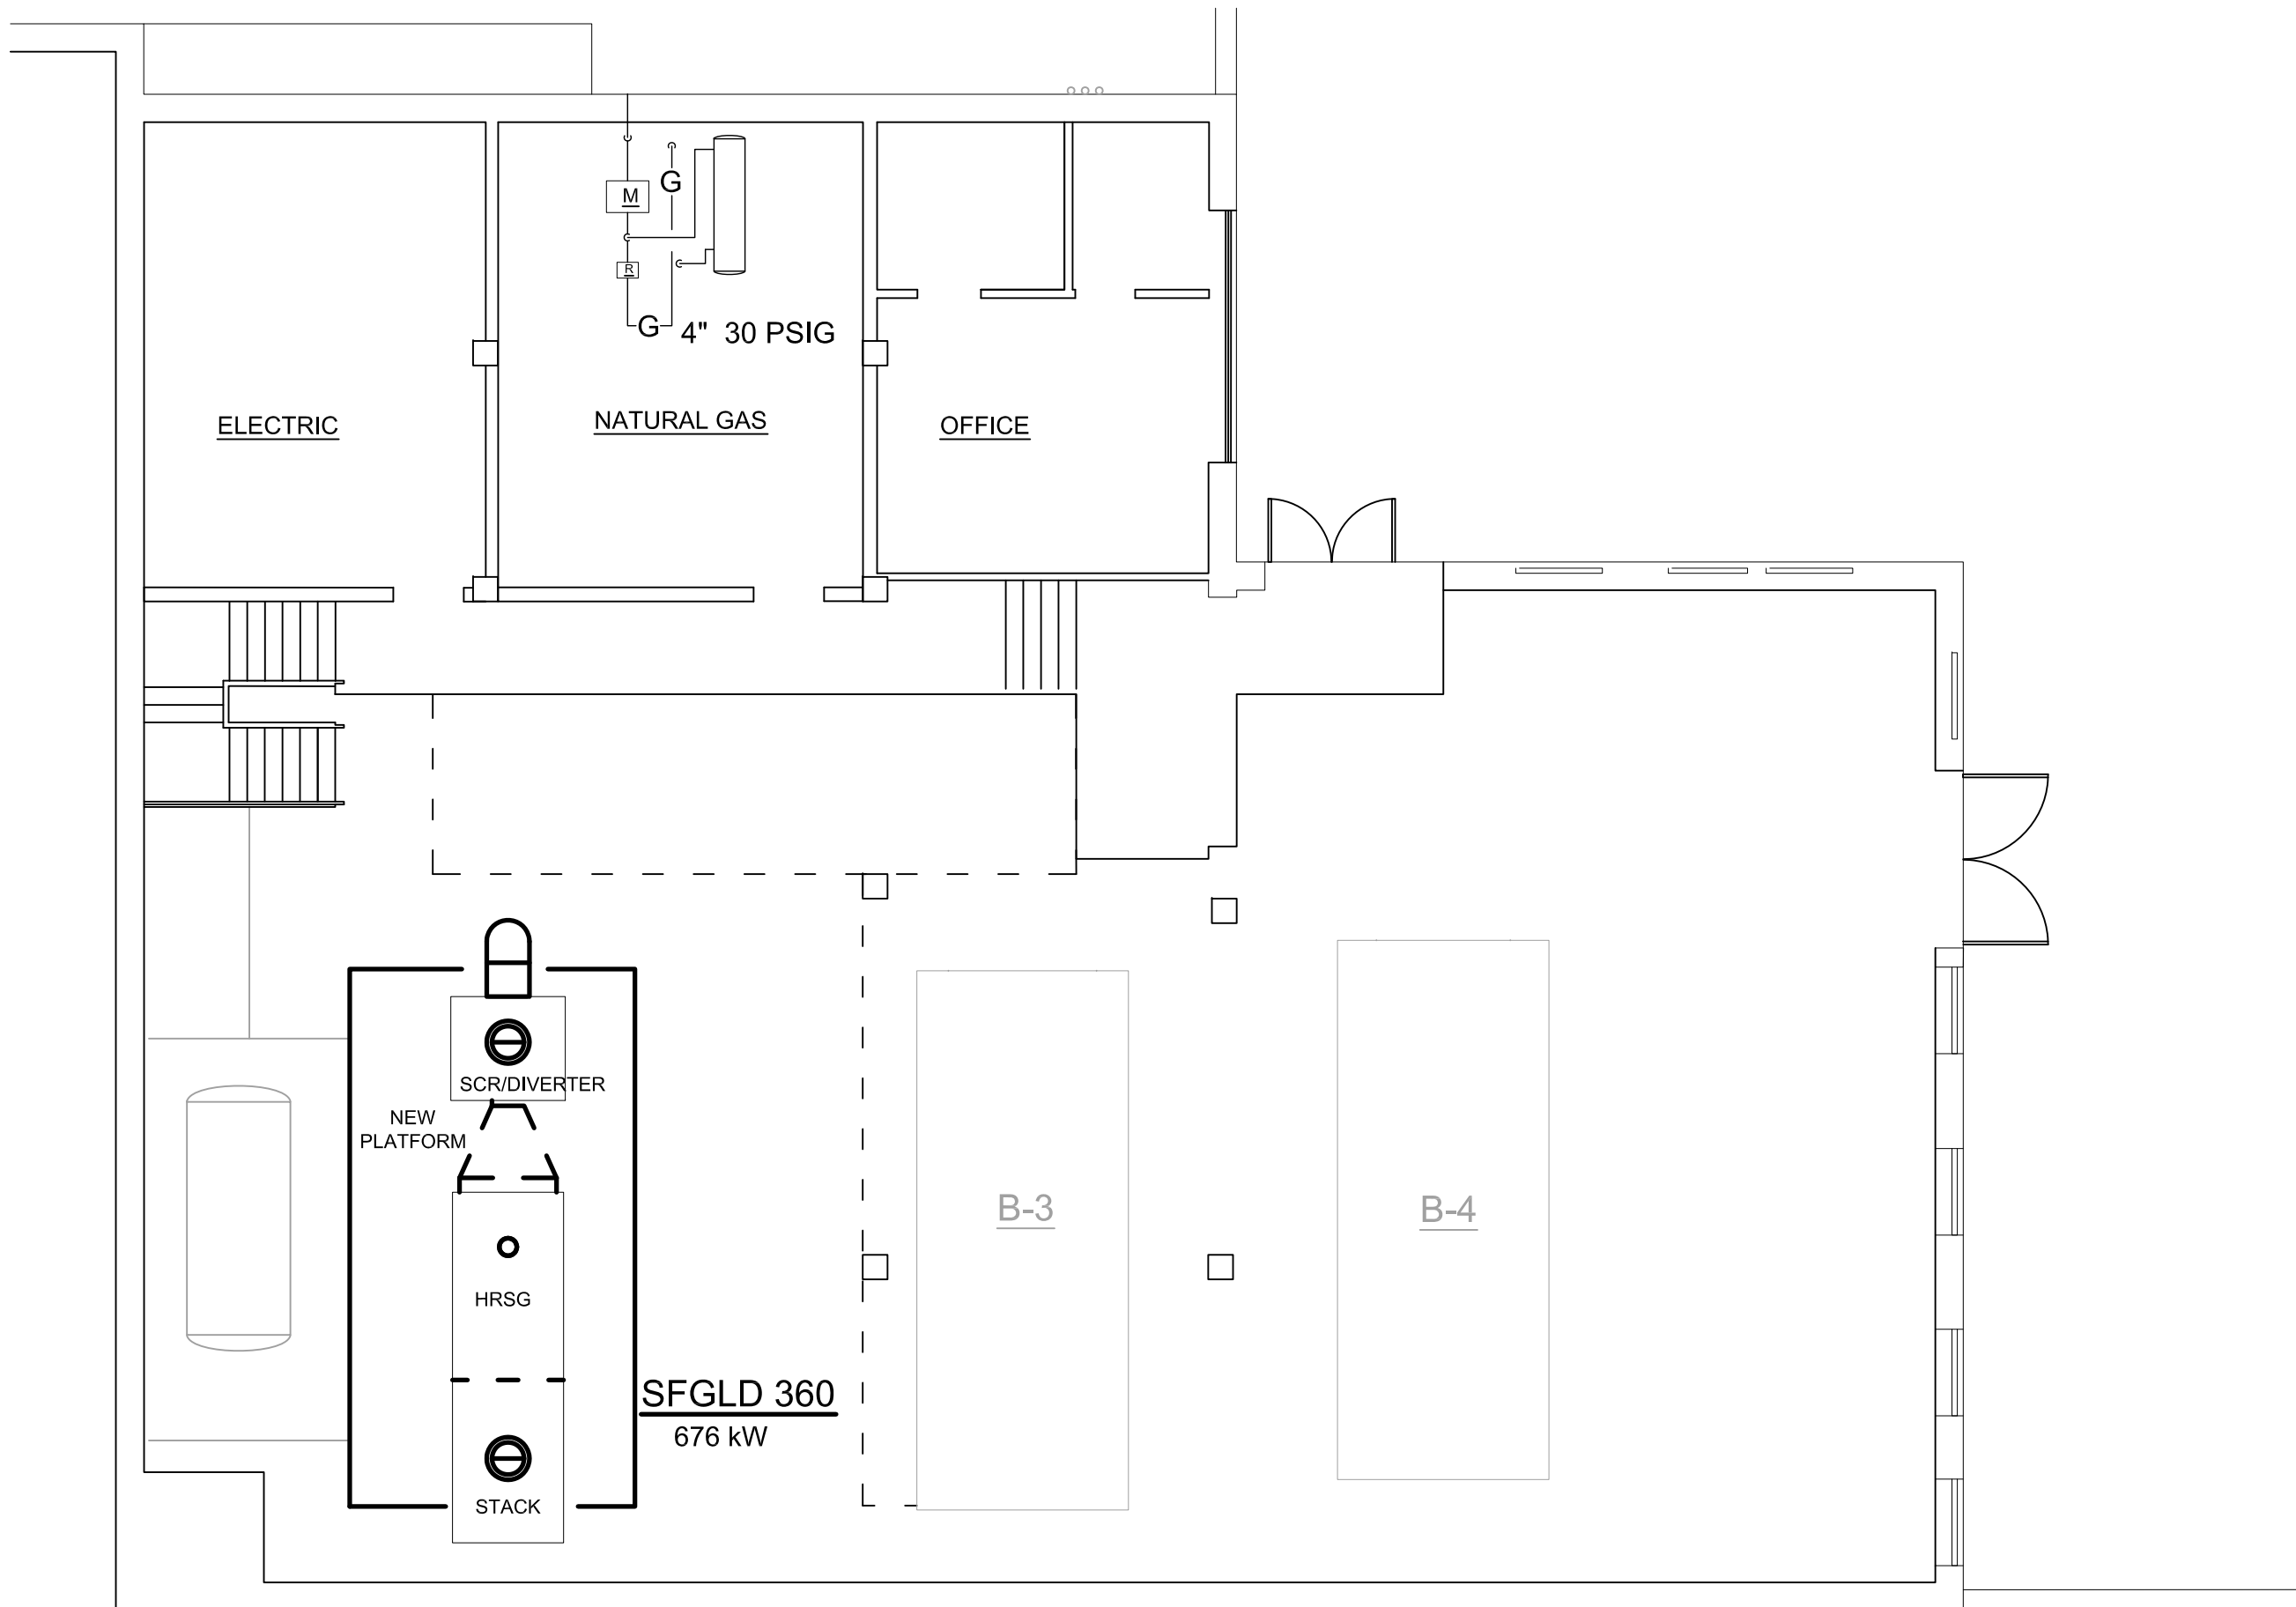

GROUND FLOOR PLAN

SCALE: $\frac{1}{8}'' = 1'0''$

SCHEMATIC DESIGN
 APPROXIMATE DIMENSIONS
 PROGRESS 01-7-13

WHIPPLE HALL PLANT
 RHODE ISLAND COLLEGE
 PROVIDENCE, RI



111 Sporn Street, Suite 410
 Framingham, Massachusetts 01701
 (888) 681-6888

ECM 9a